

**KEVIN  
CULHAN**  
*architect, llc*

P O Box 25021  
Greenville, SC 29616  
864-655-7070

2001 © 1-20-2020 ALL RIGHTS RESERVED BY KEVIN CULHAN ARCHITECT, LLC DO NOT SCALE DRAWINGS

**LOT 85 BRAXTON RIDGE**  
GALLOWAY CUSTOM HOMES

DATE	DESCRIPTION
1-17-20	PRELIM
1-24-20	PRELIM
1-29-20	UPDATE
1-30-20	UPDATE

PROJ. NO: 2001

DRAWN BY: TS

COVER


SHEET  
1 OF 10



**LOT 85 BRAXTON RIDGE**

SHEET INDEX	
1	COVER SHEET
2	SITE PLAN
3	FOUNDATION PLAN
4	FIRST FLOOR PLAN
5	SECOND FLOOR PLAN
6	ROOF PLAN
7	ELEVATION
8	ELEVATION
9	FIRST FLOOR ELECTRICAL PLAN
10	SECOND FLOOR ELECTRICAL PLAN



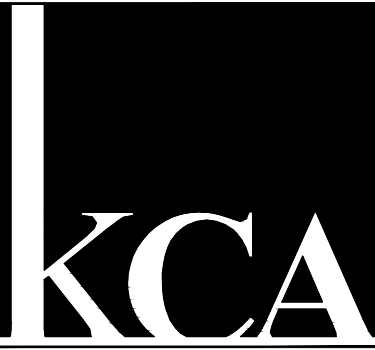

**KEVIN  
CULHAN**  
architect, llc

P O Box 25021  
Greenville, SC 29616  
864-655-7070

2001 © 1-20-2020 ALL RIGHTS RESERVED BY KEVIN CULHAN ARCHITECT, LLC DO NOT SCALE DRAWINGS

**LOT 85 BRAXTON RIDGE**  
GALLOWAY CUSTOM HOMES



DATE	DESCRIPTION
1-17-20	PRELIM
1-24-20	PRELIM
1-29-20	UPDATE
1-30-20	UPDATE

PROJ. NO: 2001

DRAWN BY: TS


SITE  
PLAN

SHEET  
2 OF 10

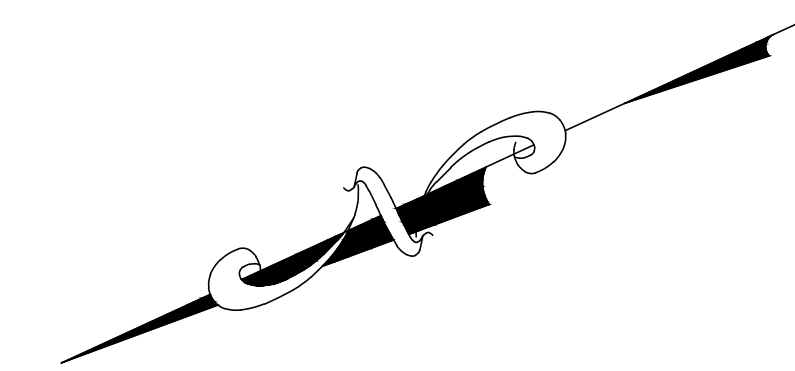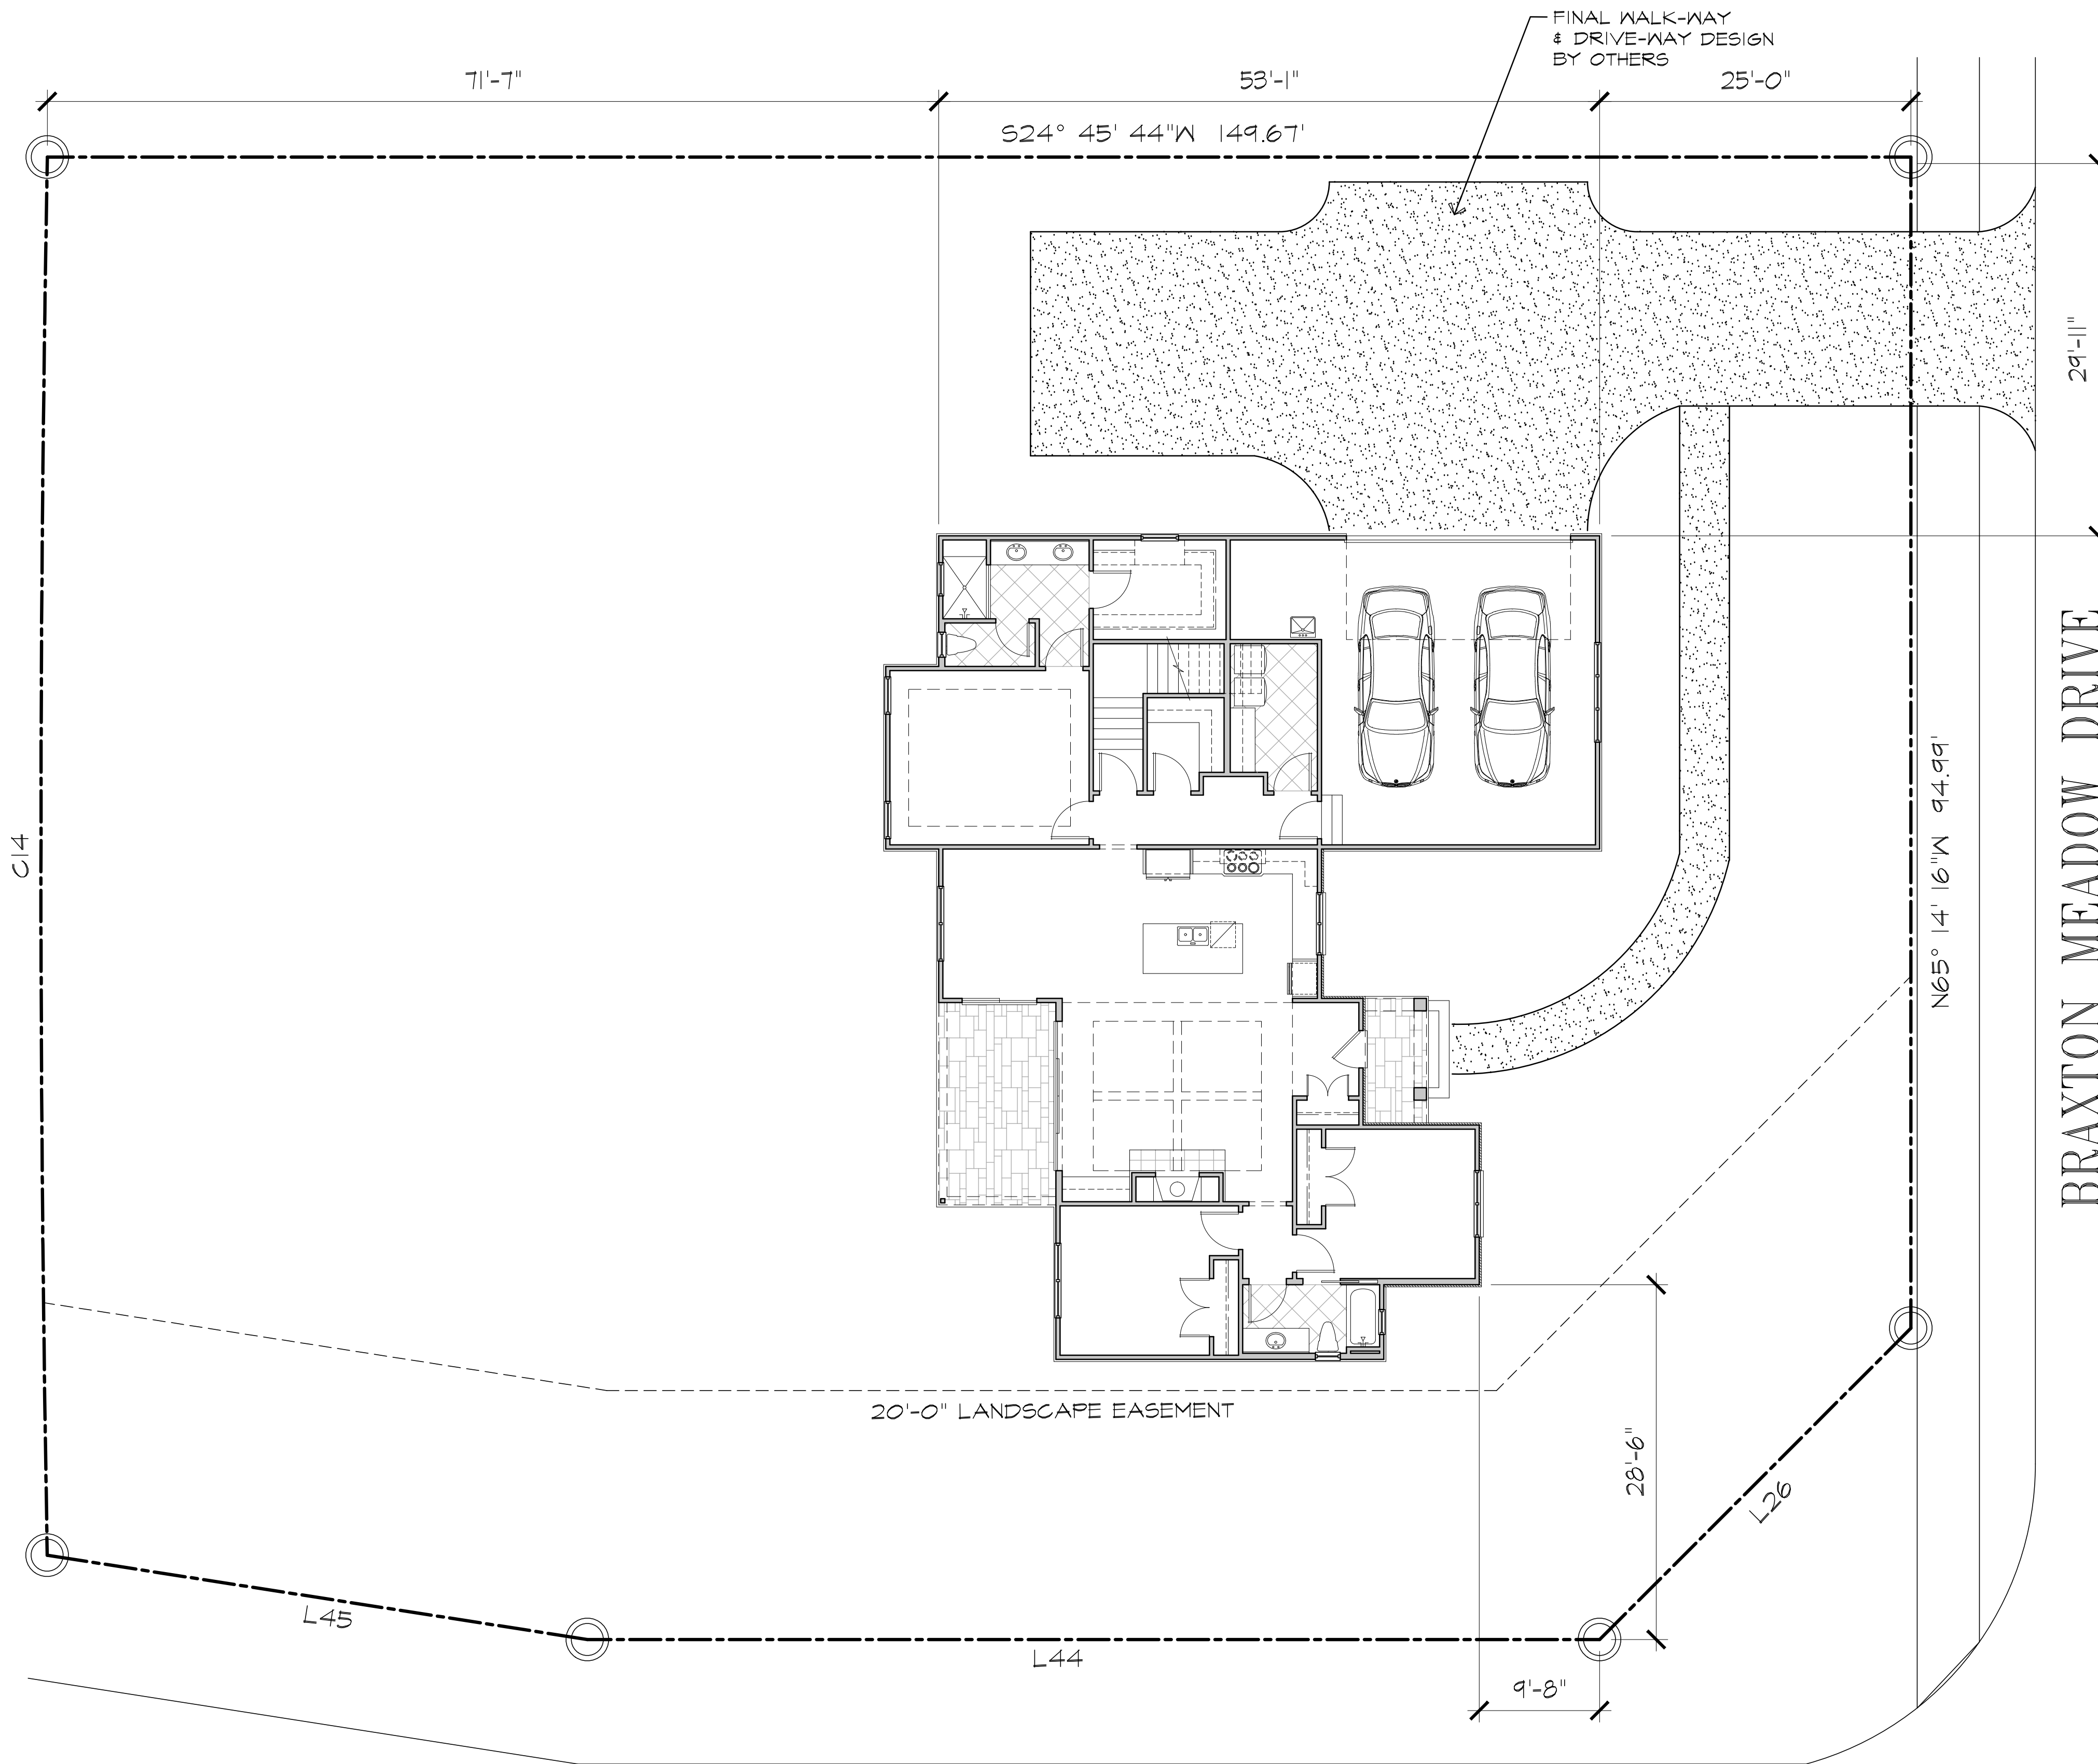

**SITE PLAN**

Scale: 1/8" = 1'-0"

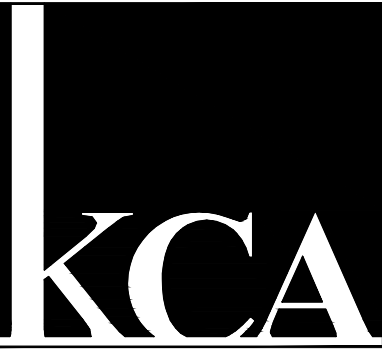


**KEVIN  
CULHAN**  
architect, llc

P O Box 25021  
Greenville, SC 29616  
864-655-7070

2001 © 1-20-2020 ALL RIGHTS RESERVED BY KEVIN CULHAN ARCHITECT, LLC DO NOT SCALE DRAWINGS

**LOT 85 BRAXTON RIDGE**  
GALLOWAY CUSTOM HOMES

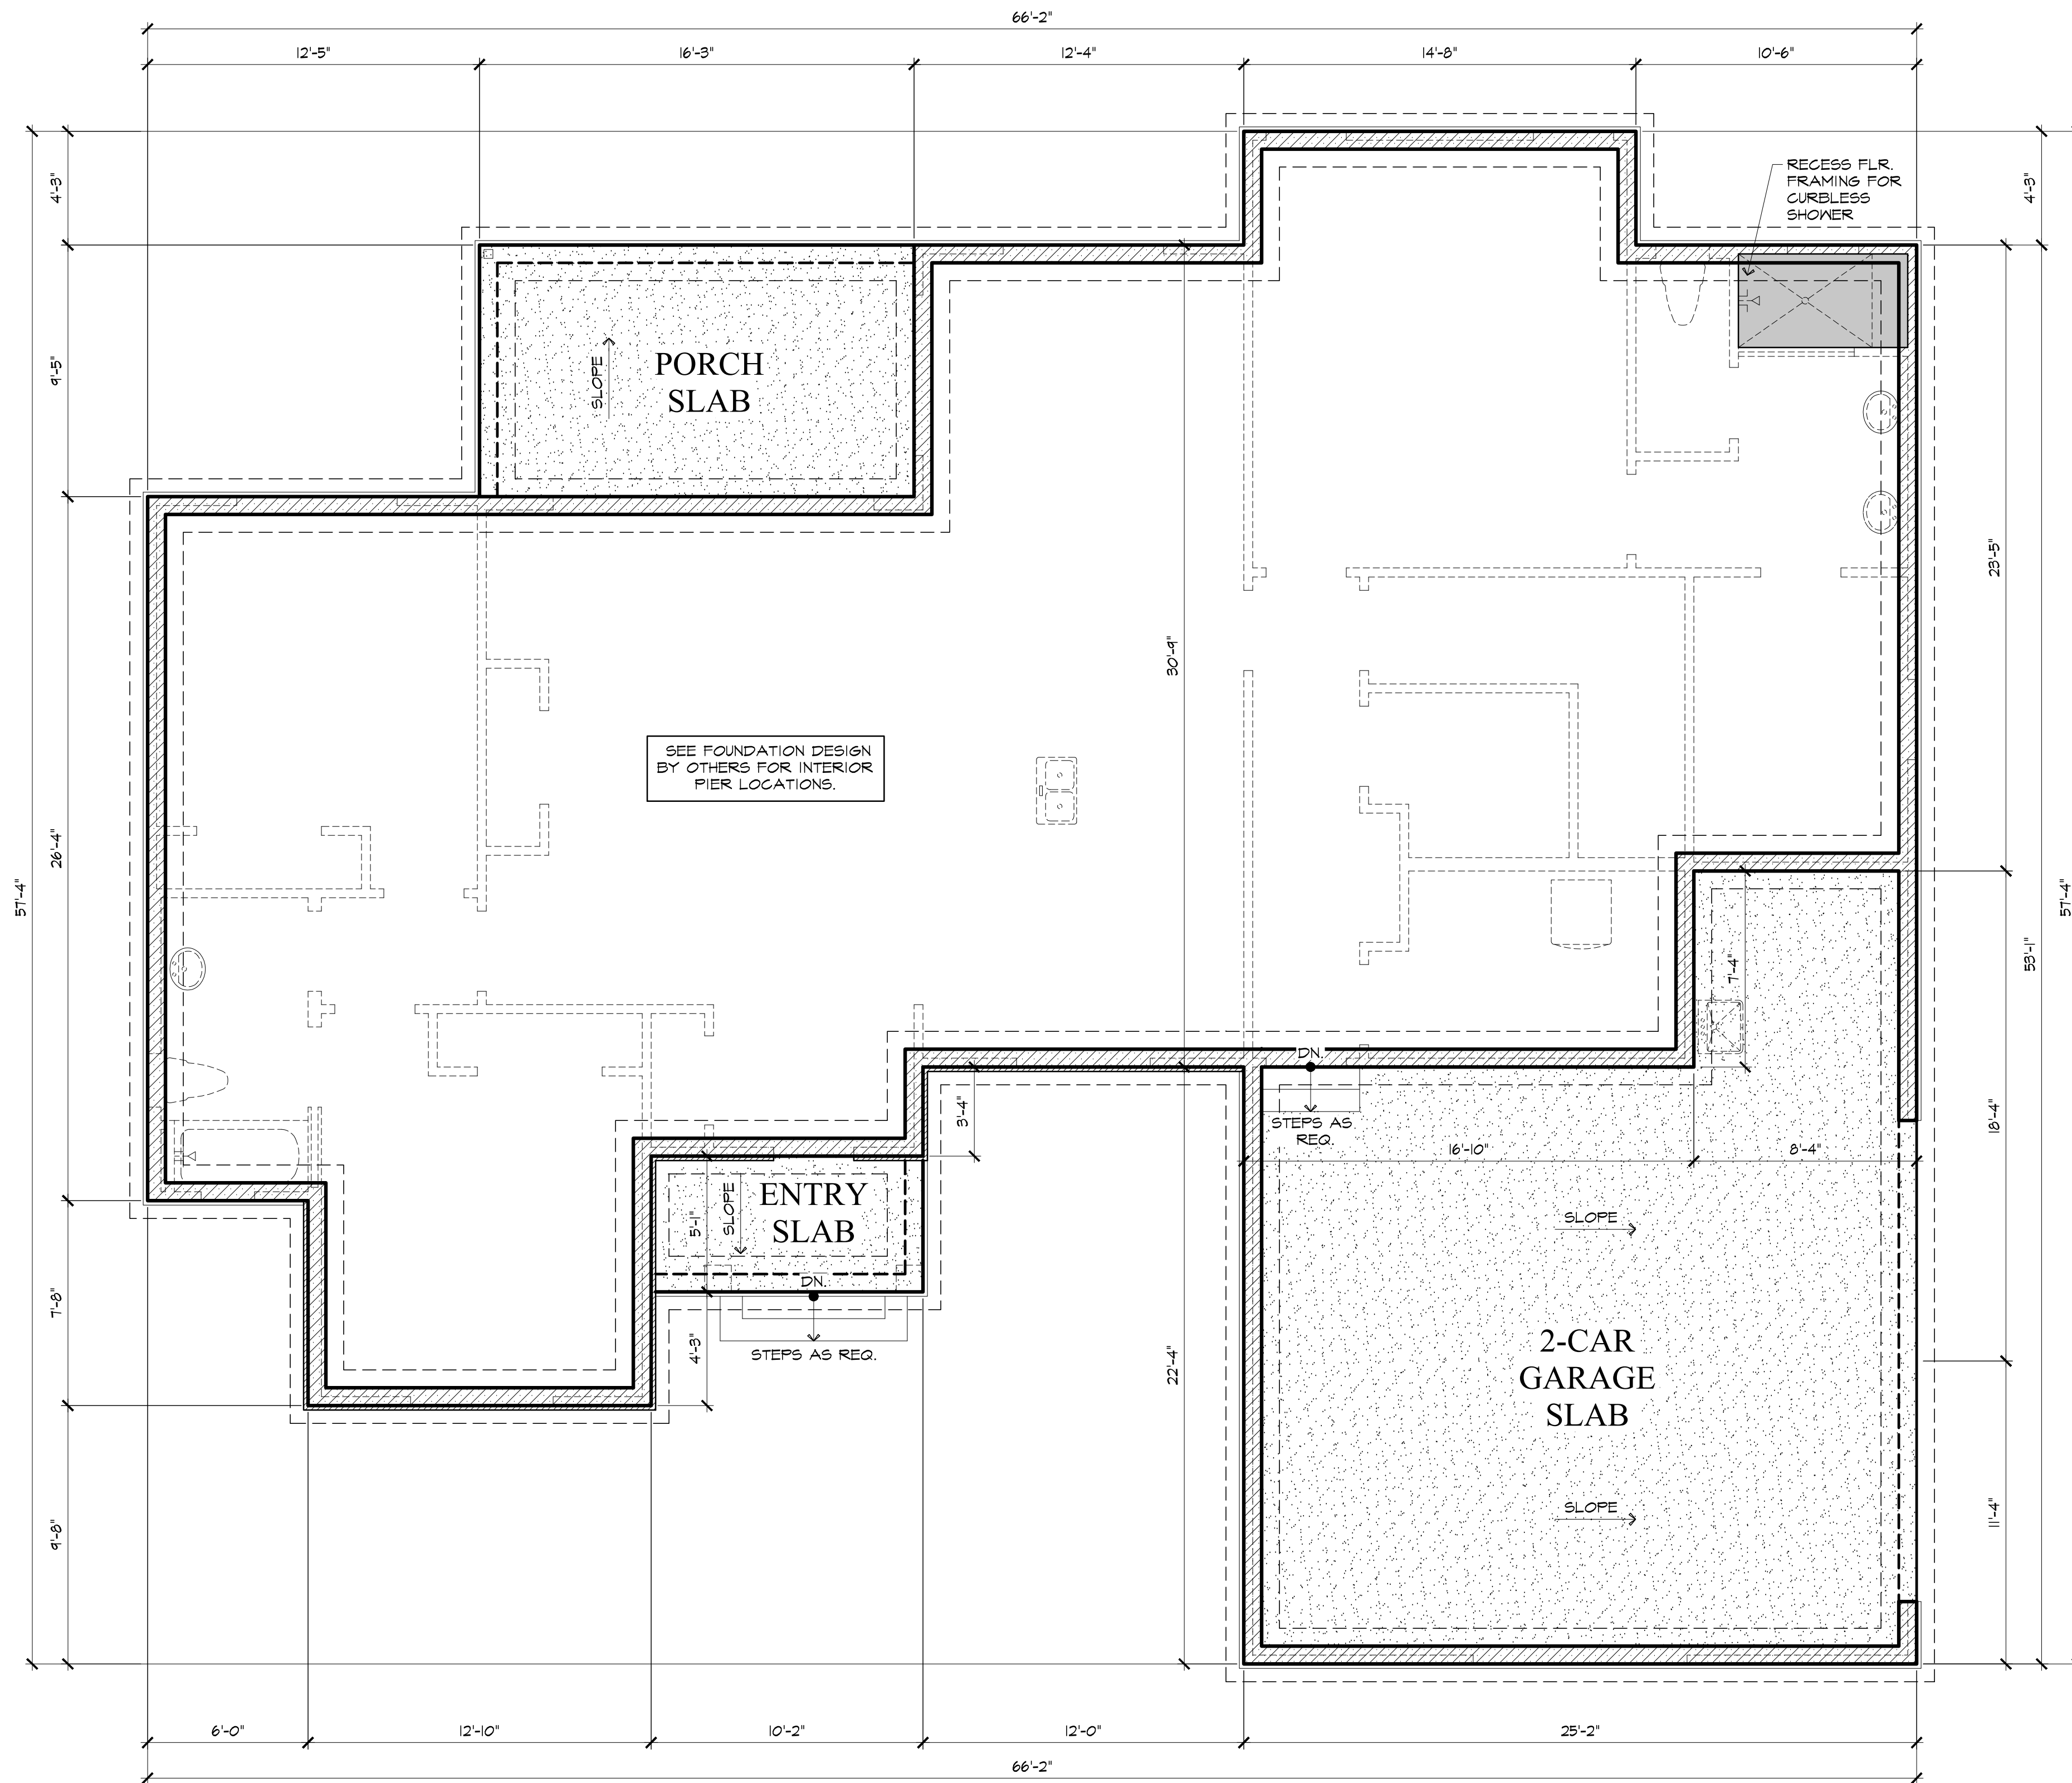

**FOUNDATION PLAN**

NOTE: THIS DRAWING IS FOR LAYOUT PURPOSES ONLY. CONTRACTOR SHALL VERIFY WITH FOUNDATION DESIGN AND FLOOR AND ROOF FRAMING DESIGN BY OTHERS

Scale: 1/4" = 1'-0"

DATE	DESCRIPTION
1-17-20	PRELIM
1-24-20	PRELIM
1-29-20	UPDATE
1-30-20	UPDATE


PROJ. NO: 2001

DRAWN BY: TS

FOUNDATION PLAN

SHEET  
3 OF 10



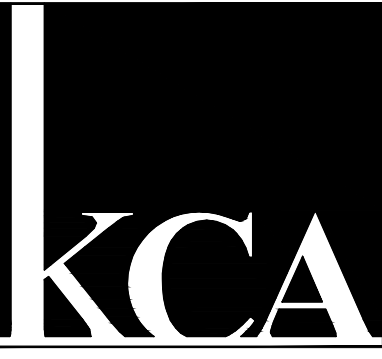


**KEVIN  
CULHAN**  
architect, llc

PO Box 25021  
Greenville, SC 29616  
864-655-7070

2001 © 1-20-2020 ALL RIGHTS RESERVED BY KEVIN CULHAN ARCHITECT, LLC DO NOT SCALE DRAWINGS

**LOT 85 BRAXTON RIDGE**  
GALLOWAY CUSTOM HOMES

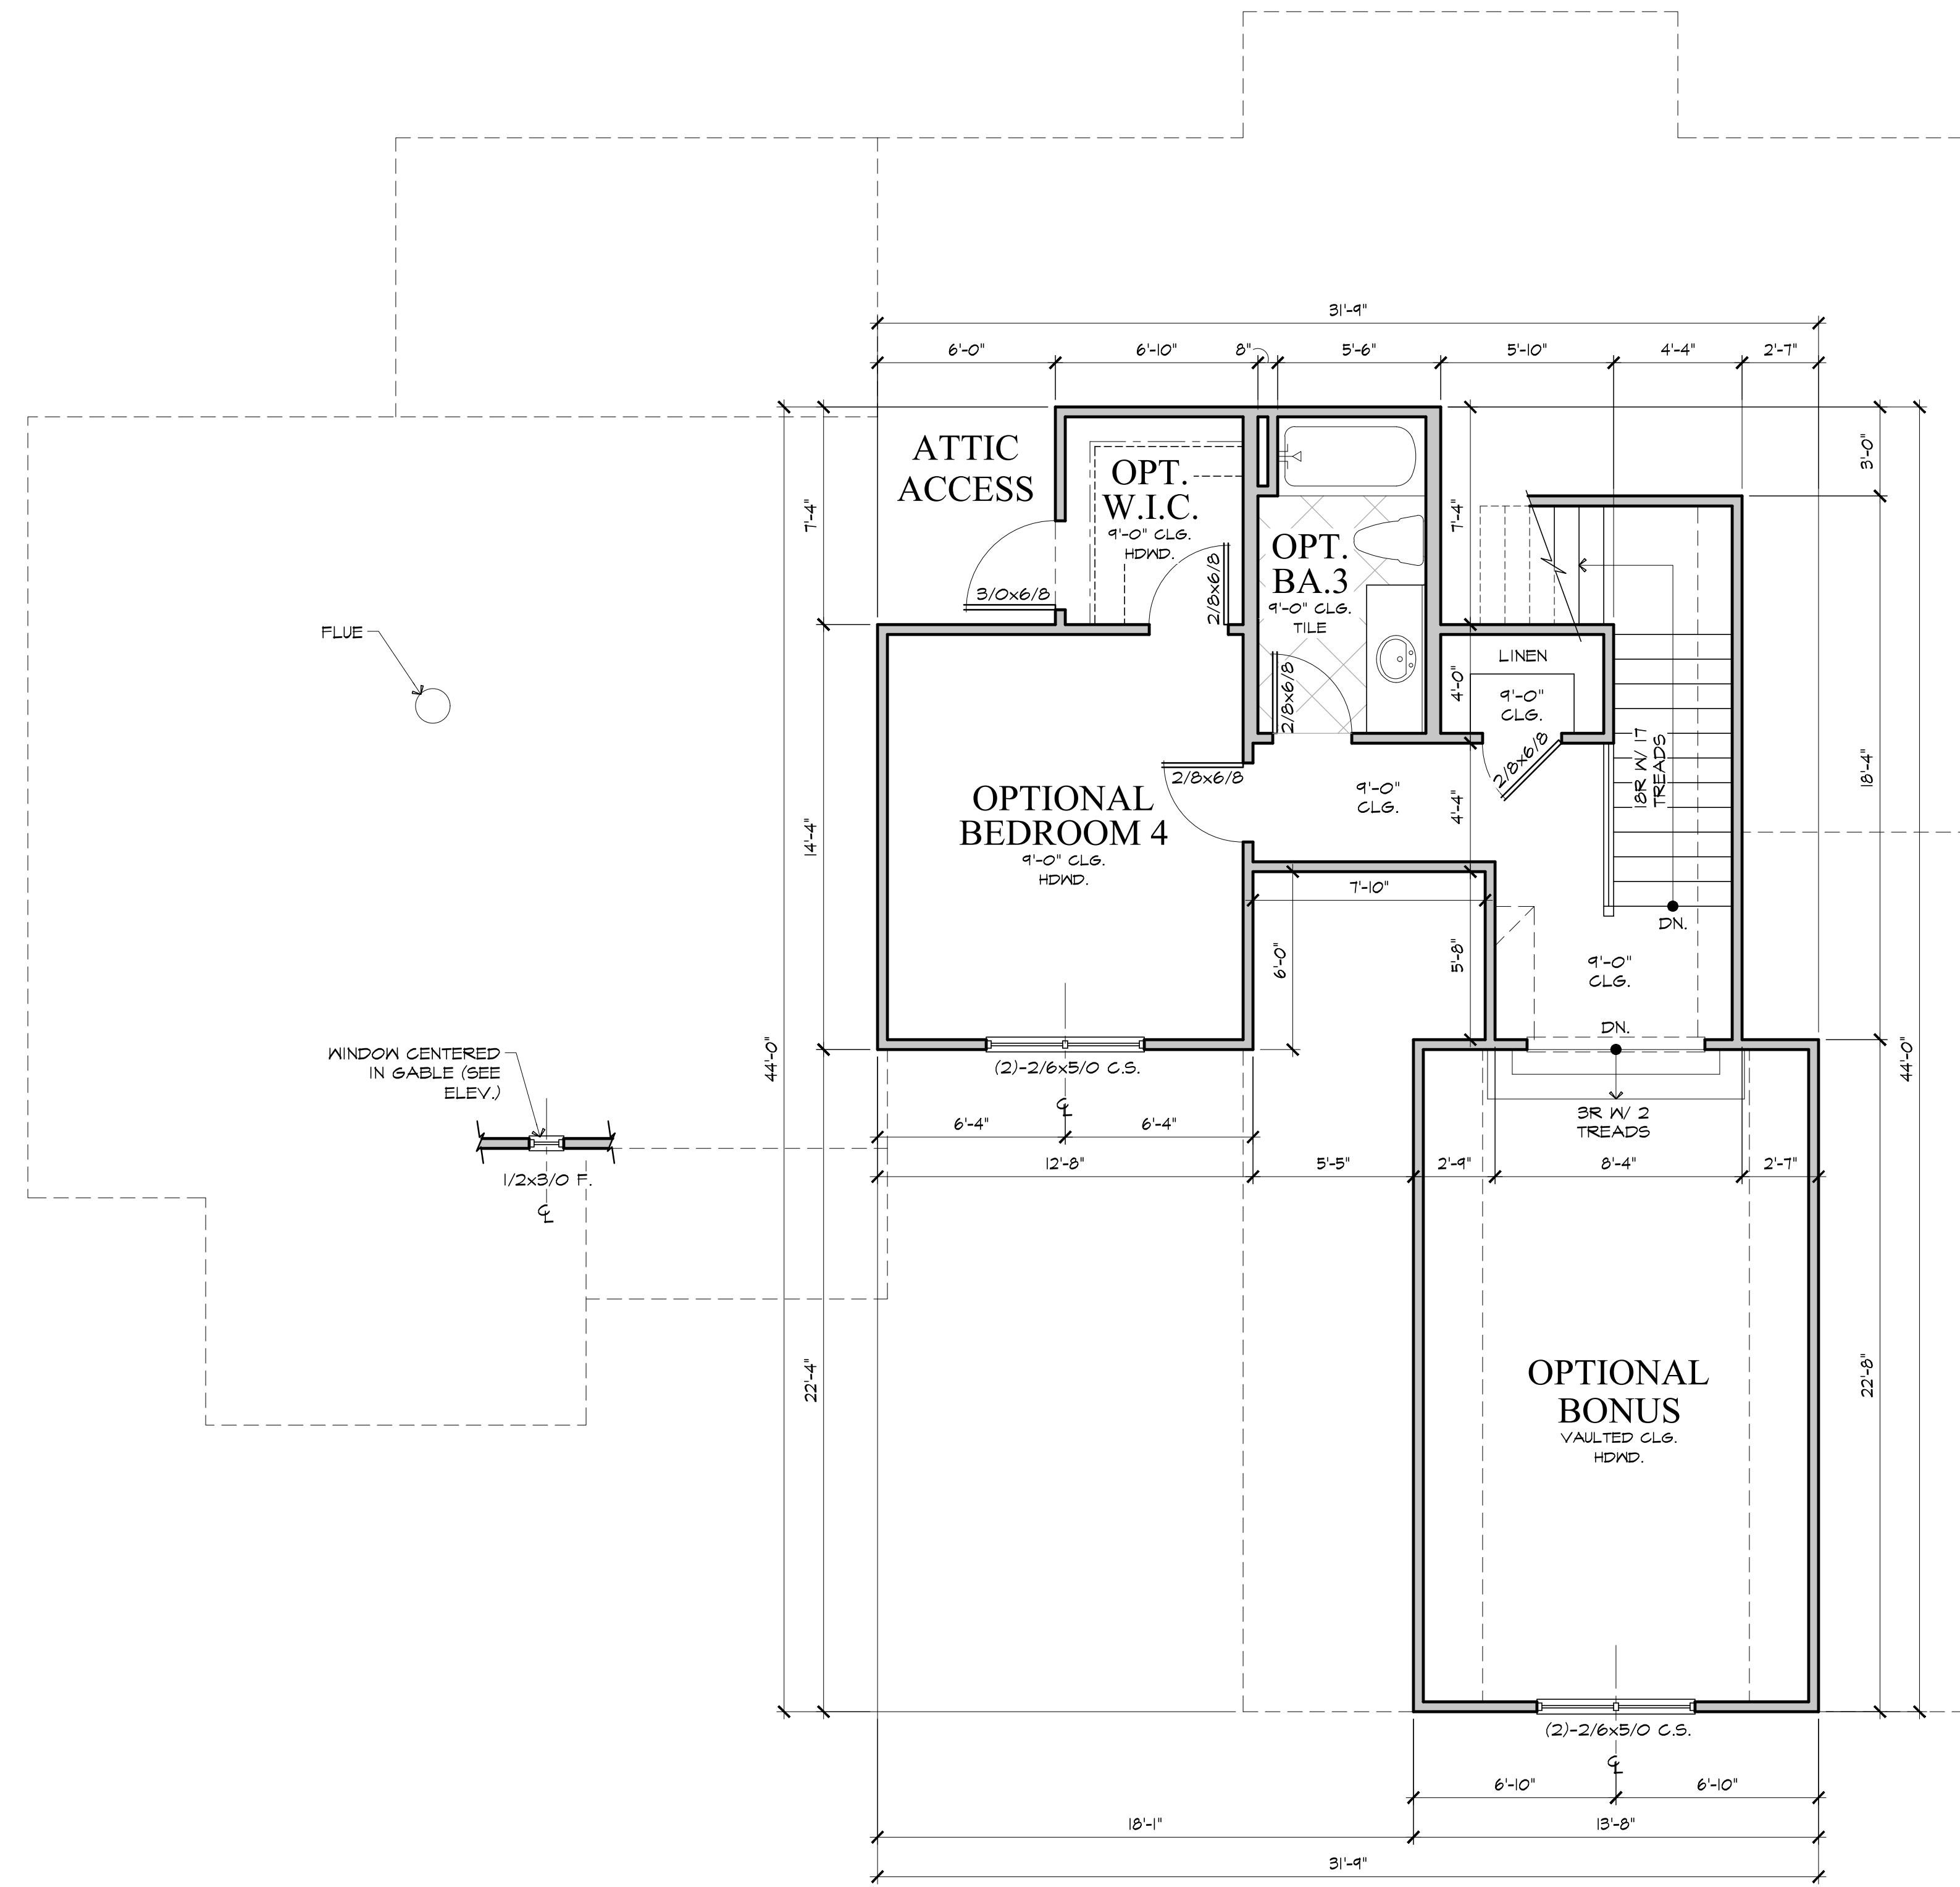

**SECOND FLOOR PLAN**

Scale: 1/4" = 1'-0"

DATE	DESCRIPTION
1-17-20	PRELIM
1-24-20	PRELIM
1-29-20	UPDATE
1-30-20	UPDATE

PROJ. NO: 2001

DRAWN BY: TS

SECOND  
FLOOR PLAN

SHEET  
2 OF 2

**LOT 85 BRAXTON RIDGE**  
GALLOWAY CUSTOM HOMES


DATE	DESCRIPTION
1-17-20	PRELIM
1-24-20	PRELIM
1-29-20	UPDATE
1-30-20	UPDATE

PROJ. NO: 2001

DRAWN BY: TS


ROOF  
PLAN

SHEET  
6 OF 10

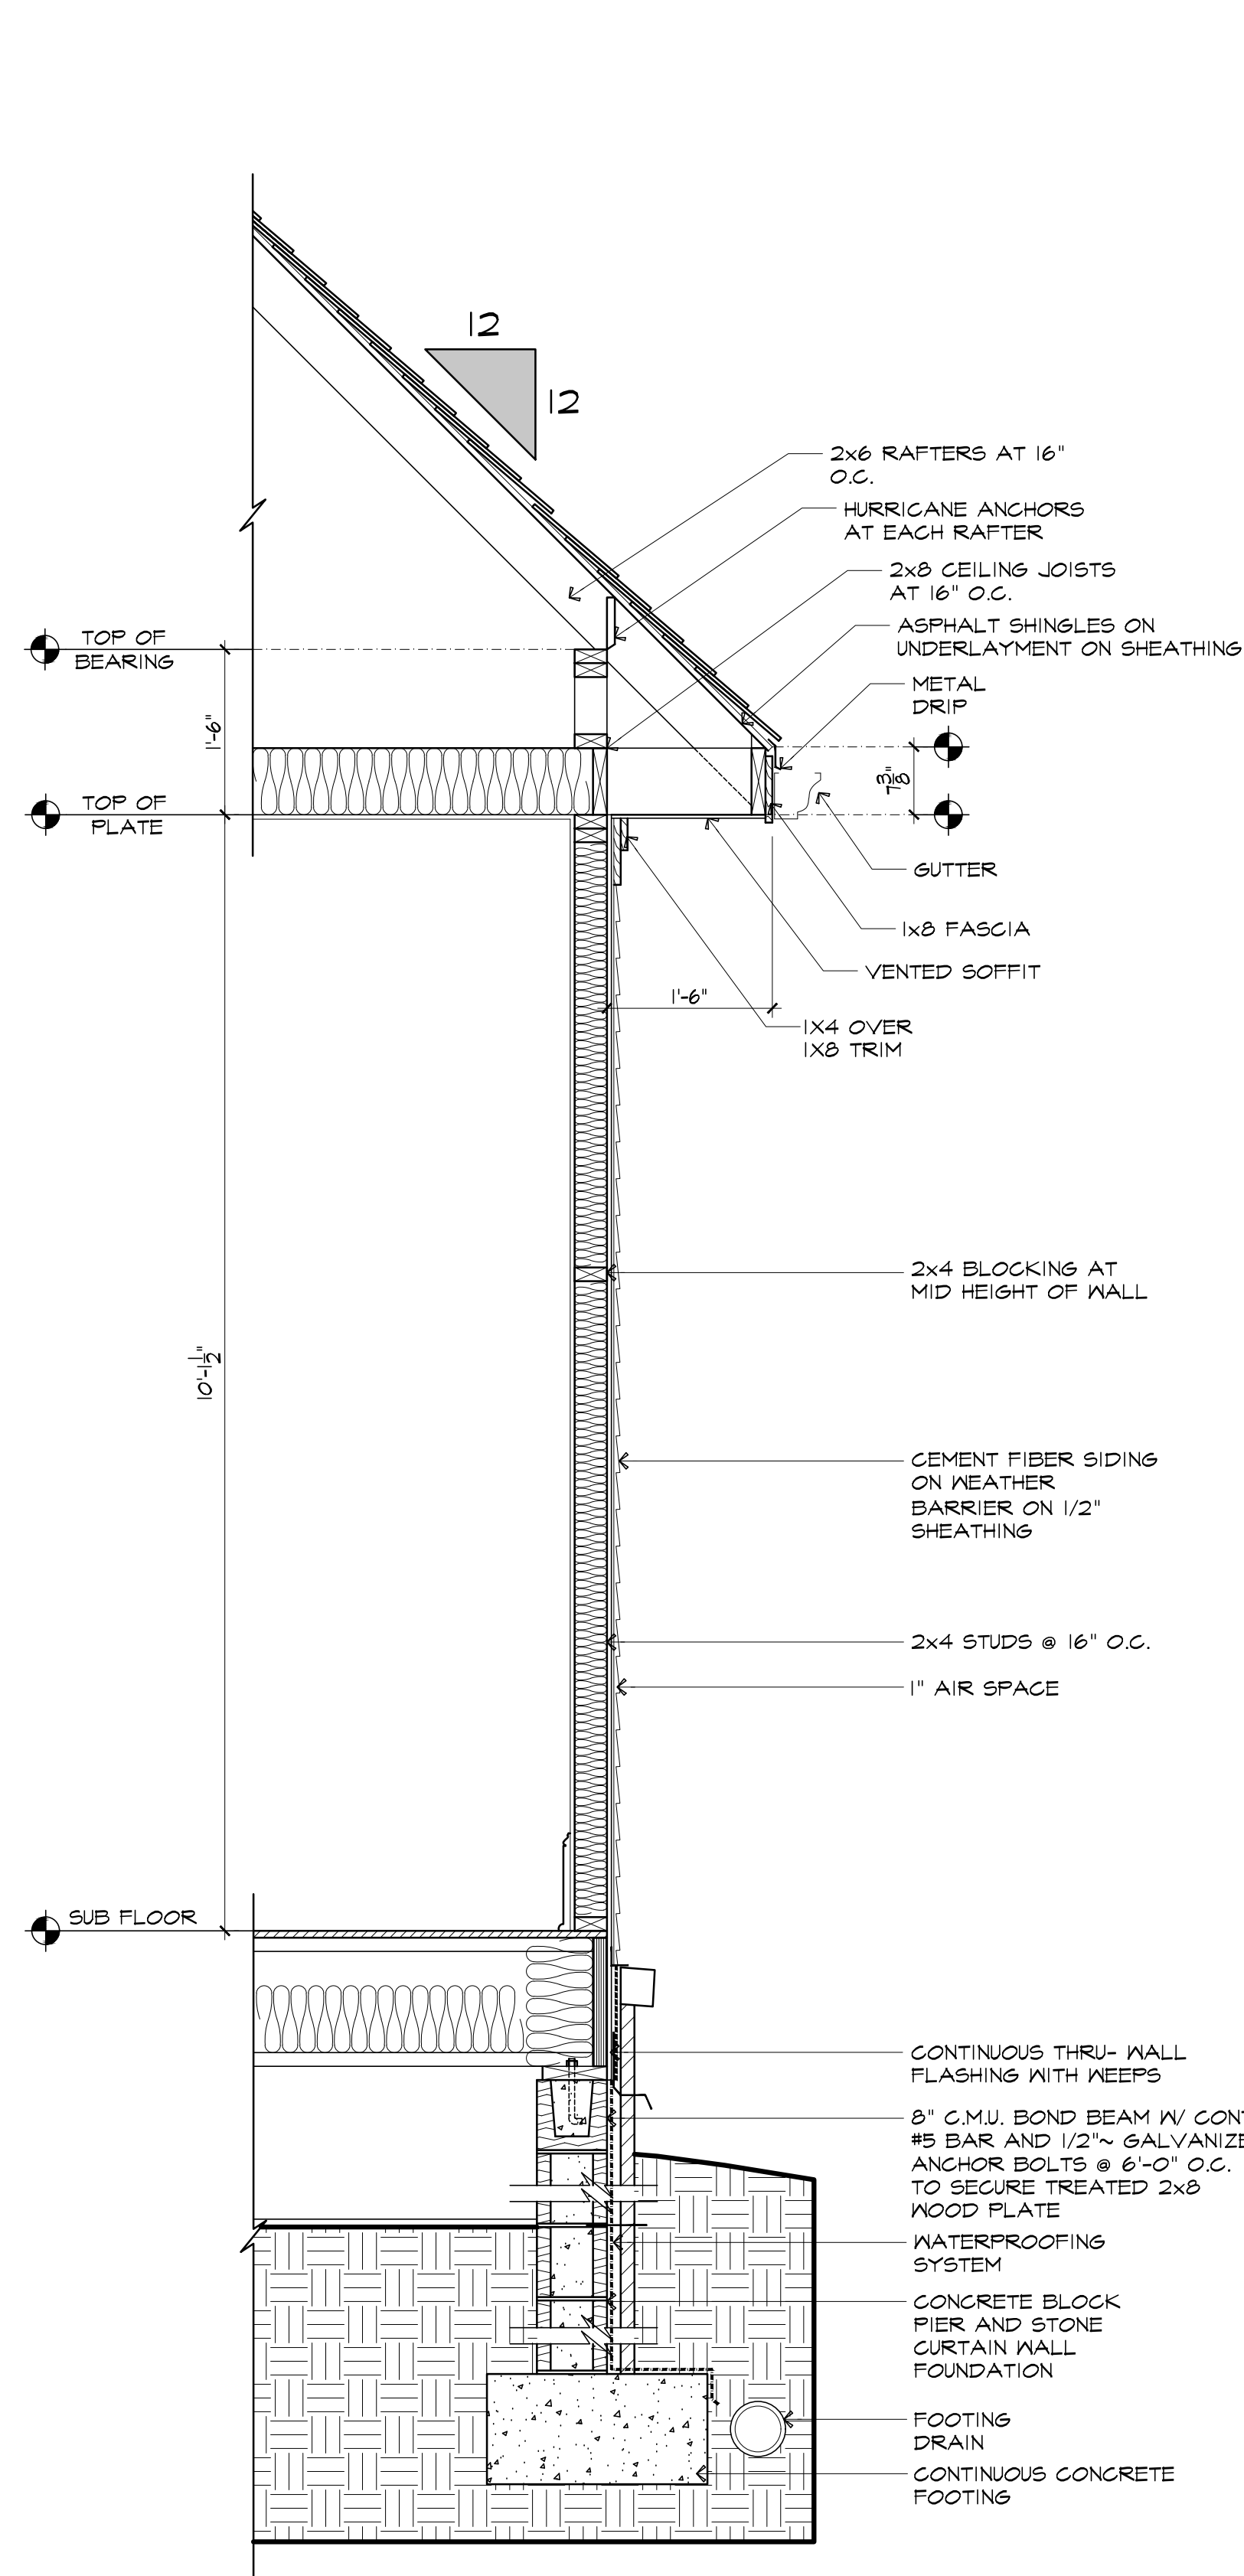

**TYPICAL STORY WALL SECTION**

Scale: 3/4" = 1'-0"

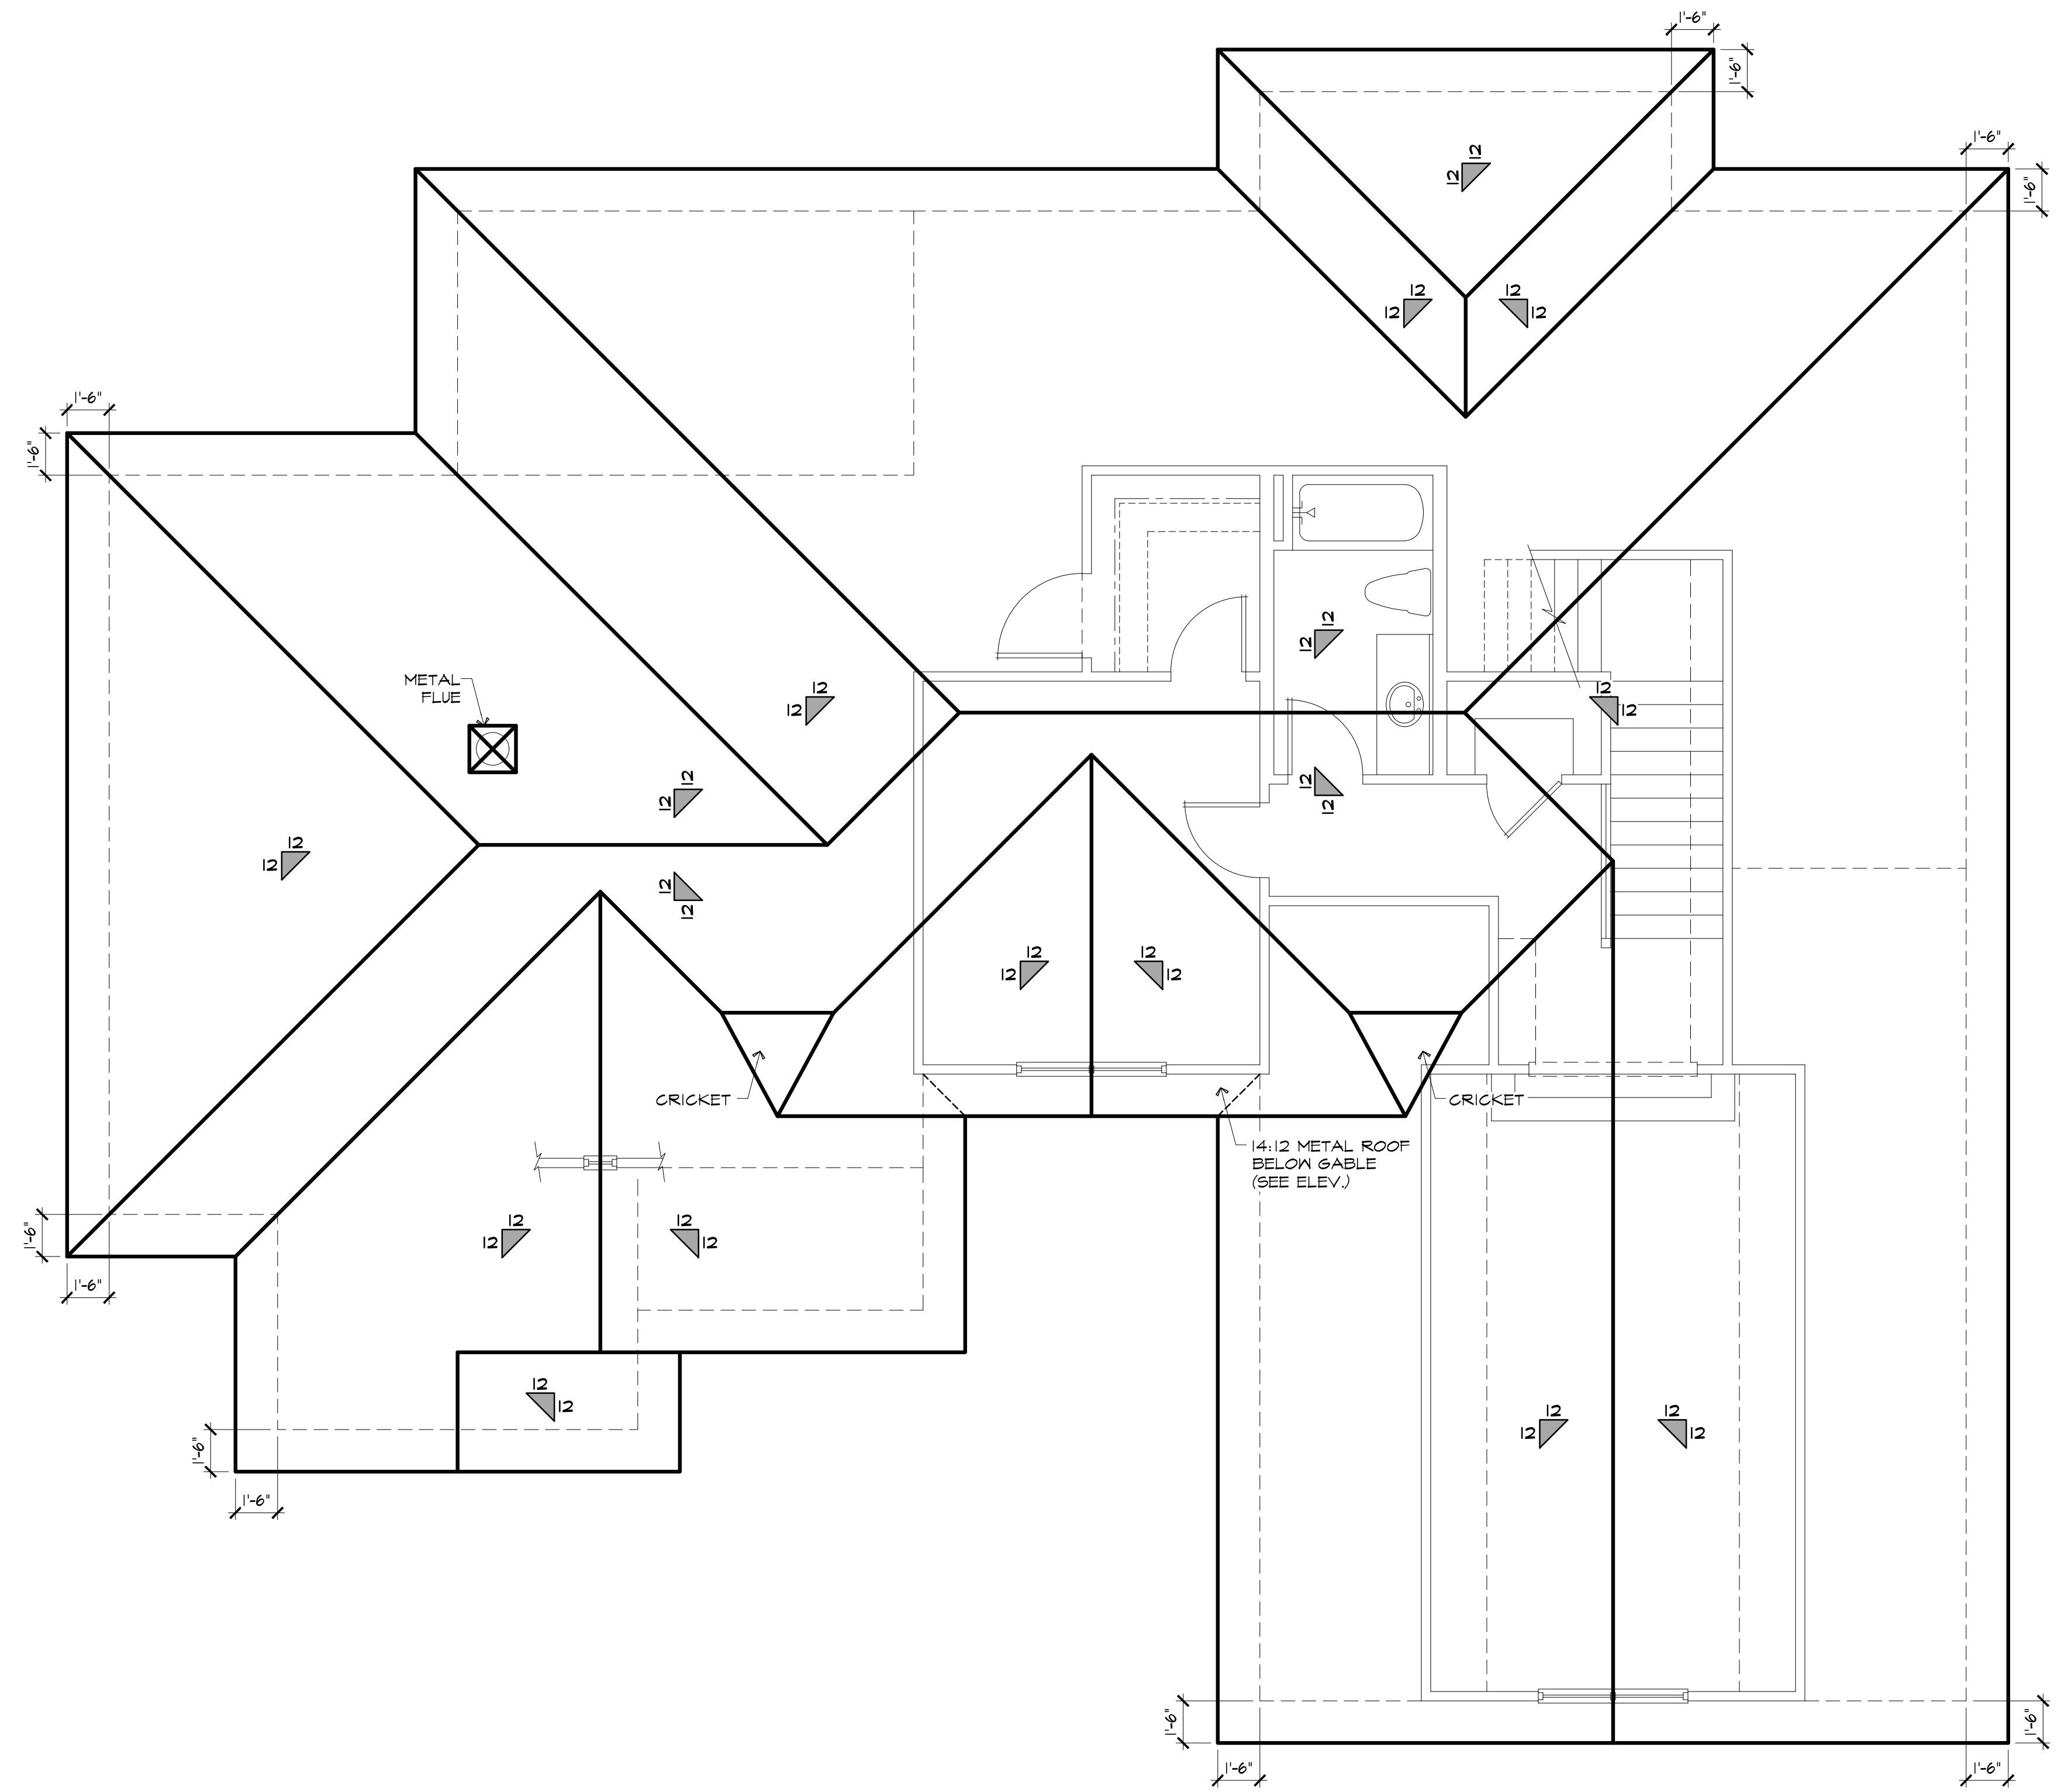

**ROOF PLAN**

Scale: 1/4" = 1'-0"




**LOT 85 BRAXTON RIDGE**  
GALLOWAY CUSTOM HOMES



**FRONT ELEVATION**

Scale: 1/4" = 1'-0"

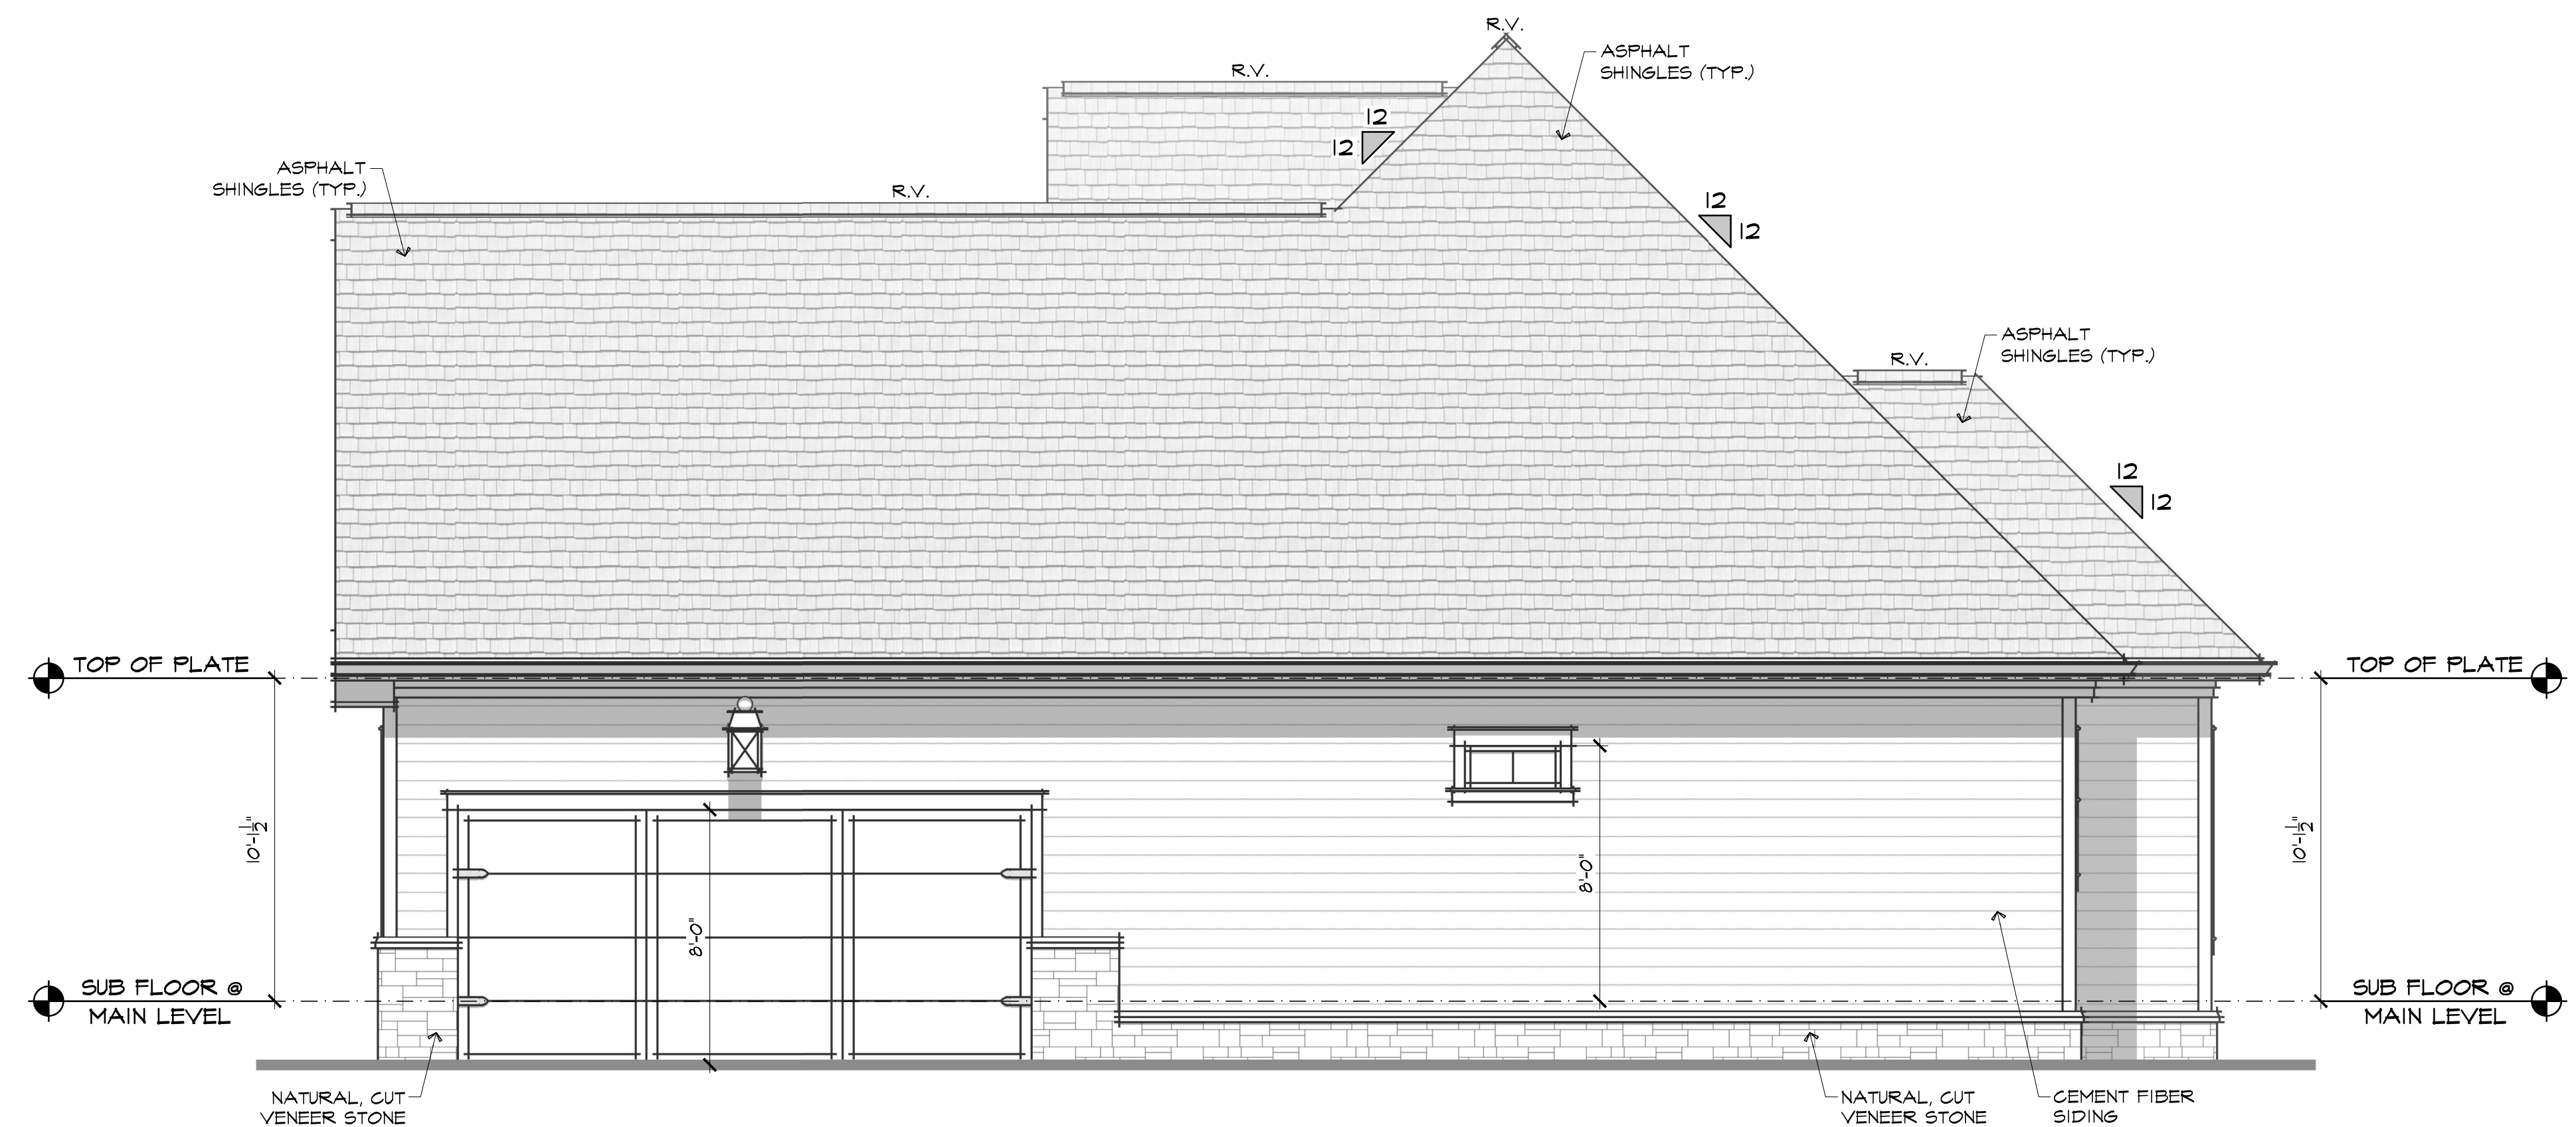

**RIGHT ELEVATION**

Scale: 1/4" = 1'-0"

DATE	DESCRIPTION
1-17-20	PRELIM
1-24-20	PRELIM
1-29-20	UPDATE
1-30-20	UPDATE

PROJ. NO: 2001

DRAWN BY: TS

ELEVATIONS

SHEET  
7 OF 10




**LOT 85 BRAXTON RIDGE**  
GALLOWAY CUSTOM HOMES



**REAR ELEVATION**

Scale: 1/4" = 1'-0"

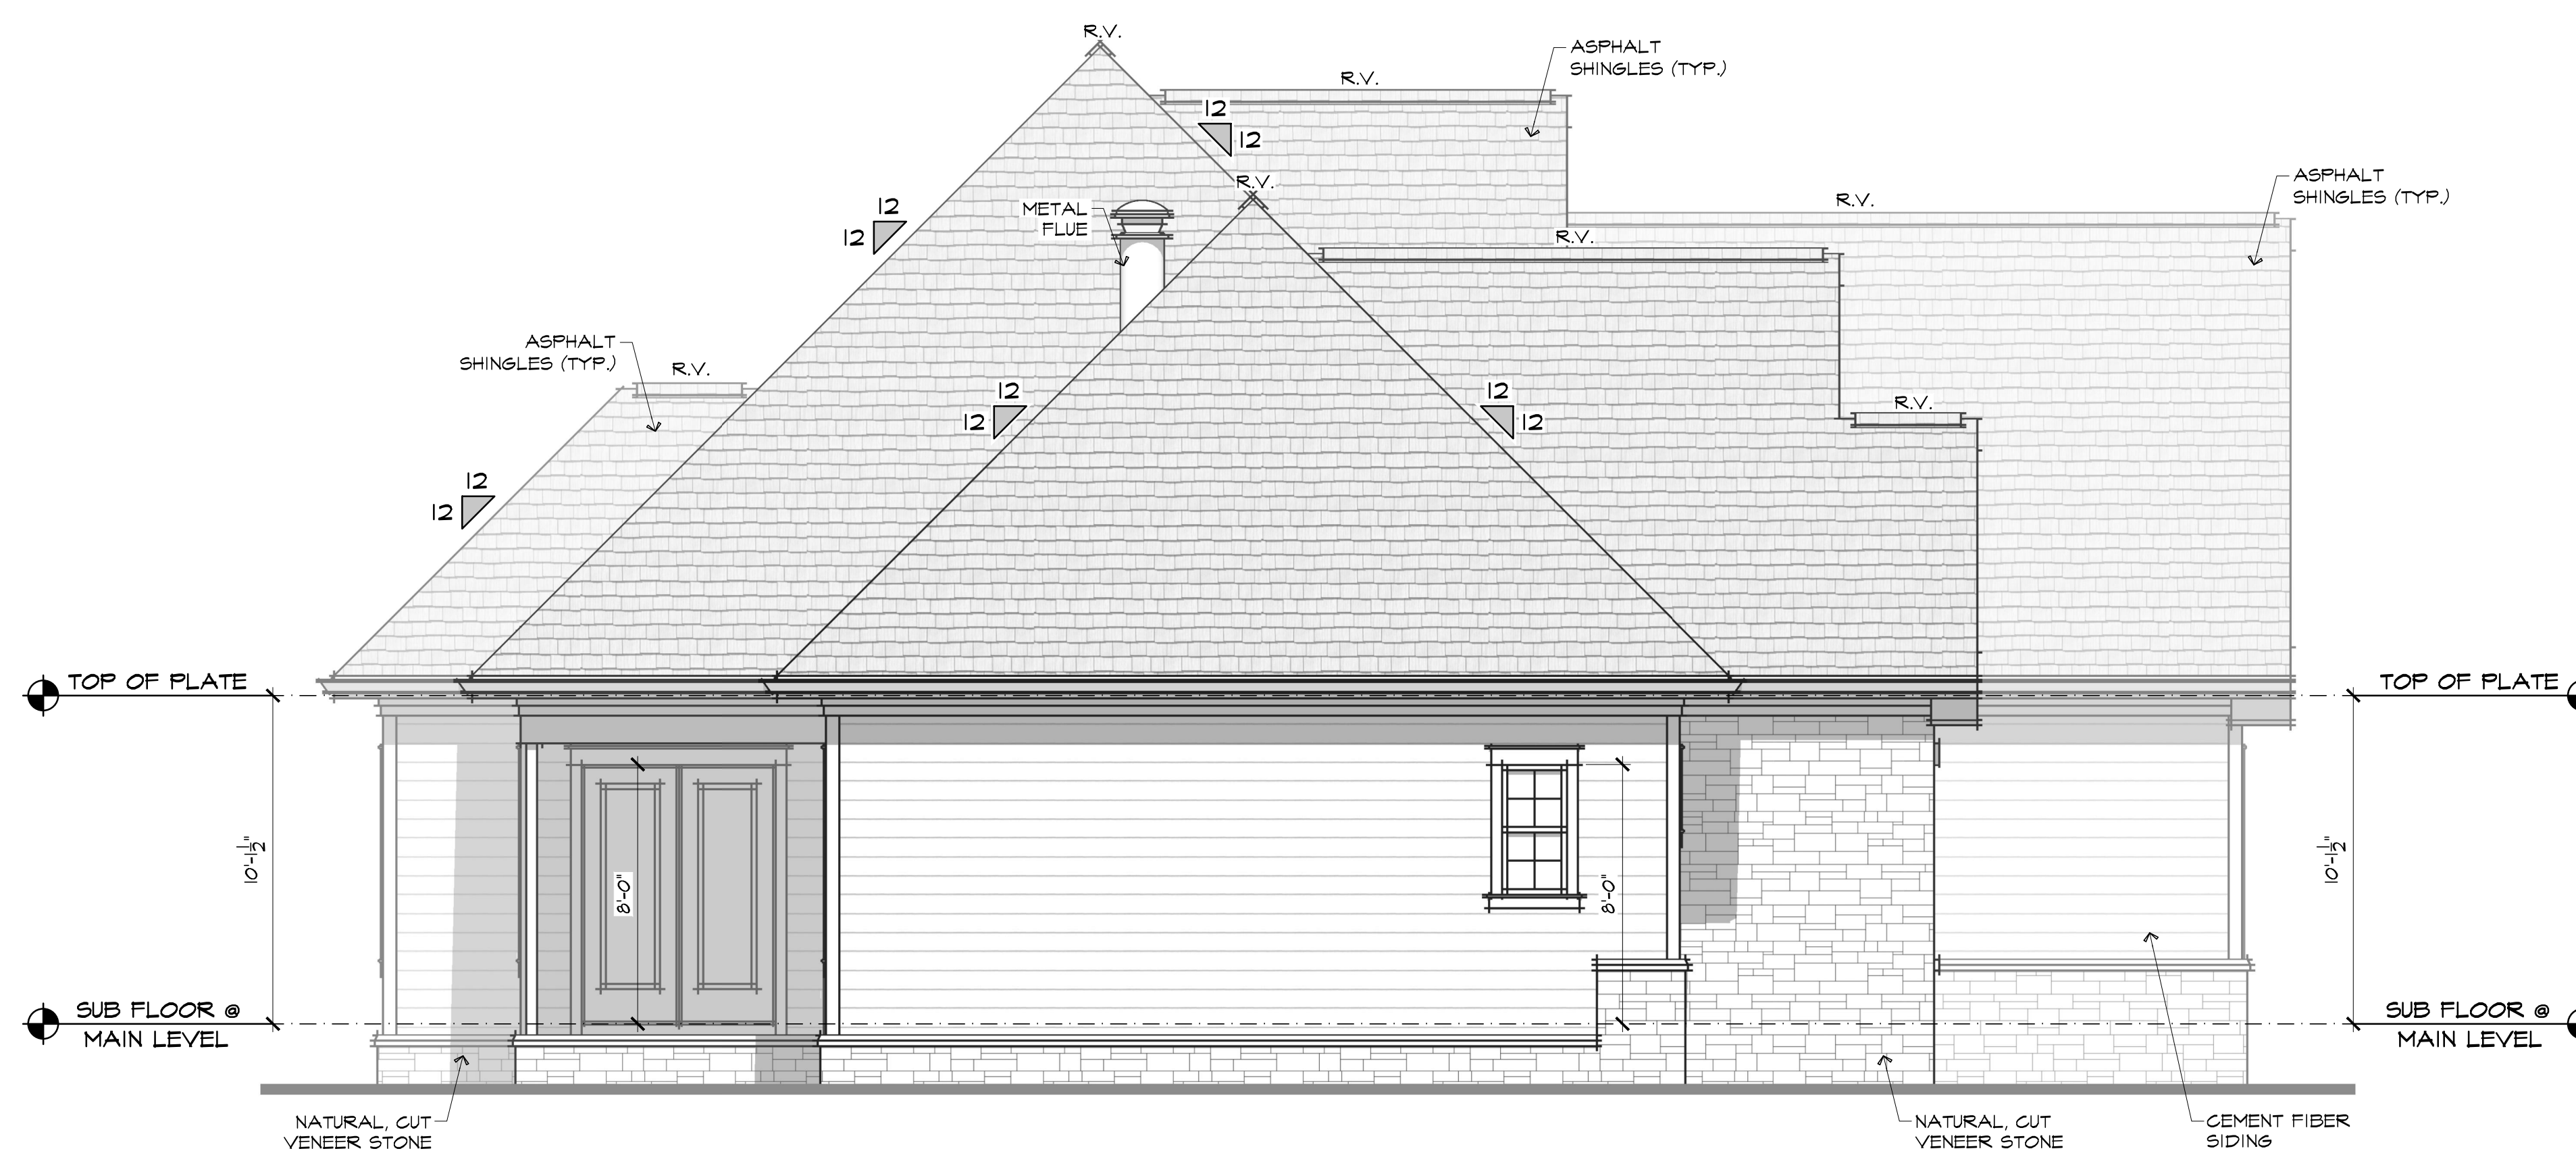

**LEFT ELEVATION**

Scale: 1/4" = 1'-0"

DATE	DESCRIPTION
1-17-20	PRELIM
1-24-20	PRELIM
1-29-20	UPDATE
1-30-20	UPDATE

PROJ. NO: 2001

DRAWN BY: TS

ELEVATION

SHEET  
8 OF 10



**LOT 85 BRAXTON RIDGE**  
GALLOWAY CUSTOM HOMES

DATE	DESCRIPTION
1-17-20	PRELIM
1-24-20	PRELIM
1-29-20	UPDATE
1-30-20	UPDATE


PROJ. NO: 2001

DRAWN BY: TS

FIRST FLOOR  
ELECTRICAL


SHEET  
9 OF 10

ELECTRICAL SCHEDULE	
SYMBOL	DESCRIPTION
⌚	SINGLE POLE SWITCH
⊕	110V OUTLET
⊕	110V HALF HOT OUTLET
⊕ <sub>220v</sub>	220V OUTLET
⊕	WALL / COUNTERTOP OUTLET
⊕	FLOOR OUTLET
⊕	DEDICATED OUTLET
⊕	TELEPHONE OUTLET
⊕	TELEVISION OUTLET
⊕	CEILING MOUNTED FIXTURE
⊕	WALL MOUNTED FIXTURE
⊕	3" RECESSED CAN FIXTURE
⊕	RECESSED CAN FIXTURE
⊕	RECESSED CAN FIXTURE - VAPOR PROOF
⊕	AIMABLE RECESSED CAN FIXTURE
⊕	EXHAUST FAN
⊕	COVE LIGHTING
⊕	FLUORESCENT FIXTURE
⊕	OVER OR UNDERCOUNTER LIGHTING
⊕	FLOOD LIGHTING
⊕	GARAGE DOOR OPENER
⊕	DISCONNECT SWITCH
⊕	CEILING FAN
⊕	FAN WITH LIGHT
⊕	VP-----VAPOR PROOF
⊕	WP-----WEATHER PROOF
⊕	GF-----GROUND FAULT INTERRUPTER
⊕	LV-----LOW VOLTAGE
NOTE: ALL OUTLETS IN KITCHEN, GARAGE AND BATHROOMS TO BE G.F.I.	
INSTALL PHONE DATA, T.V. OUTLETS PER OWNERS SPECIFICATIONS	

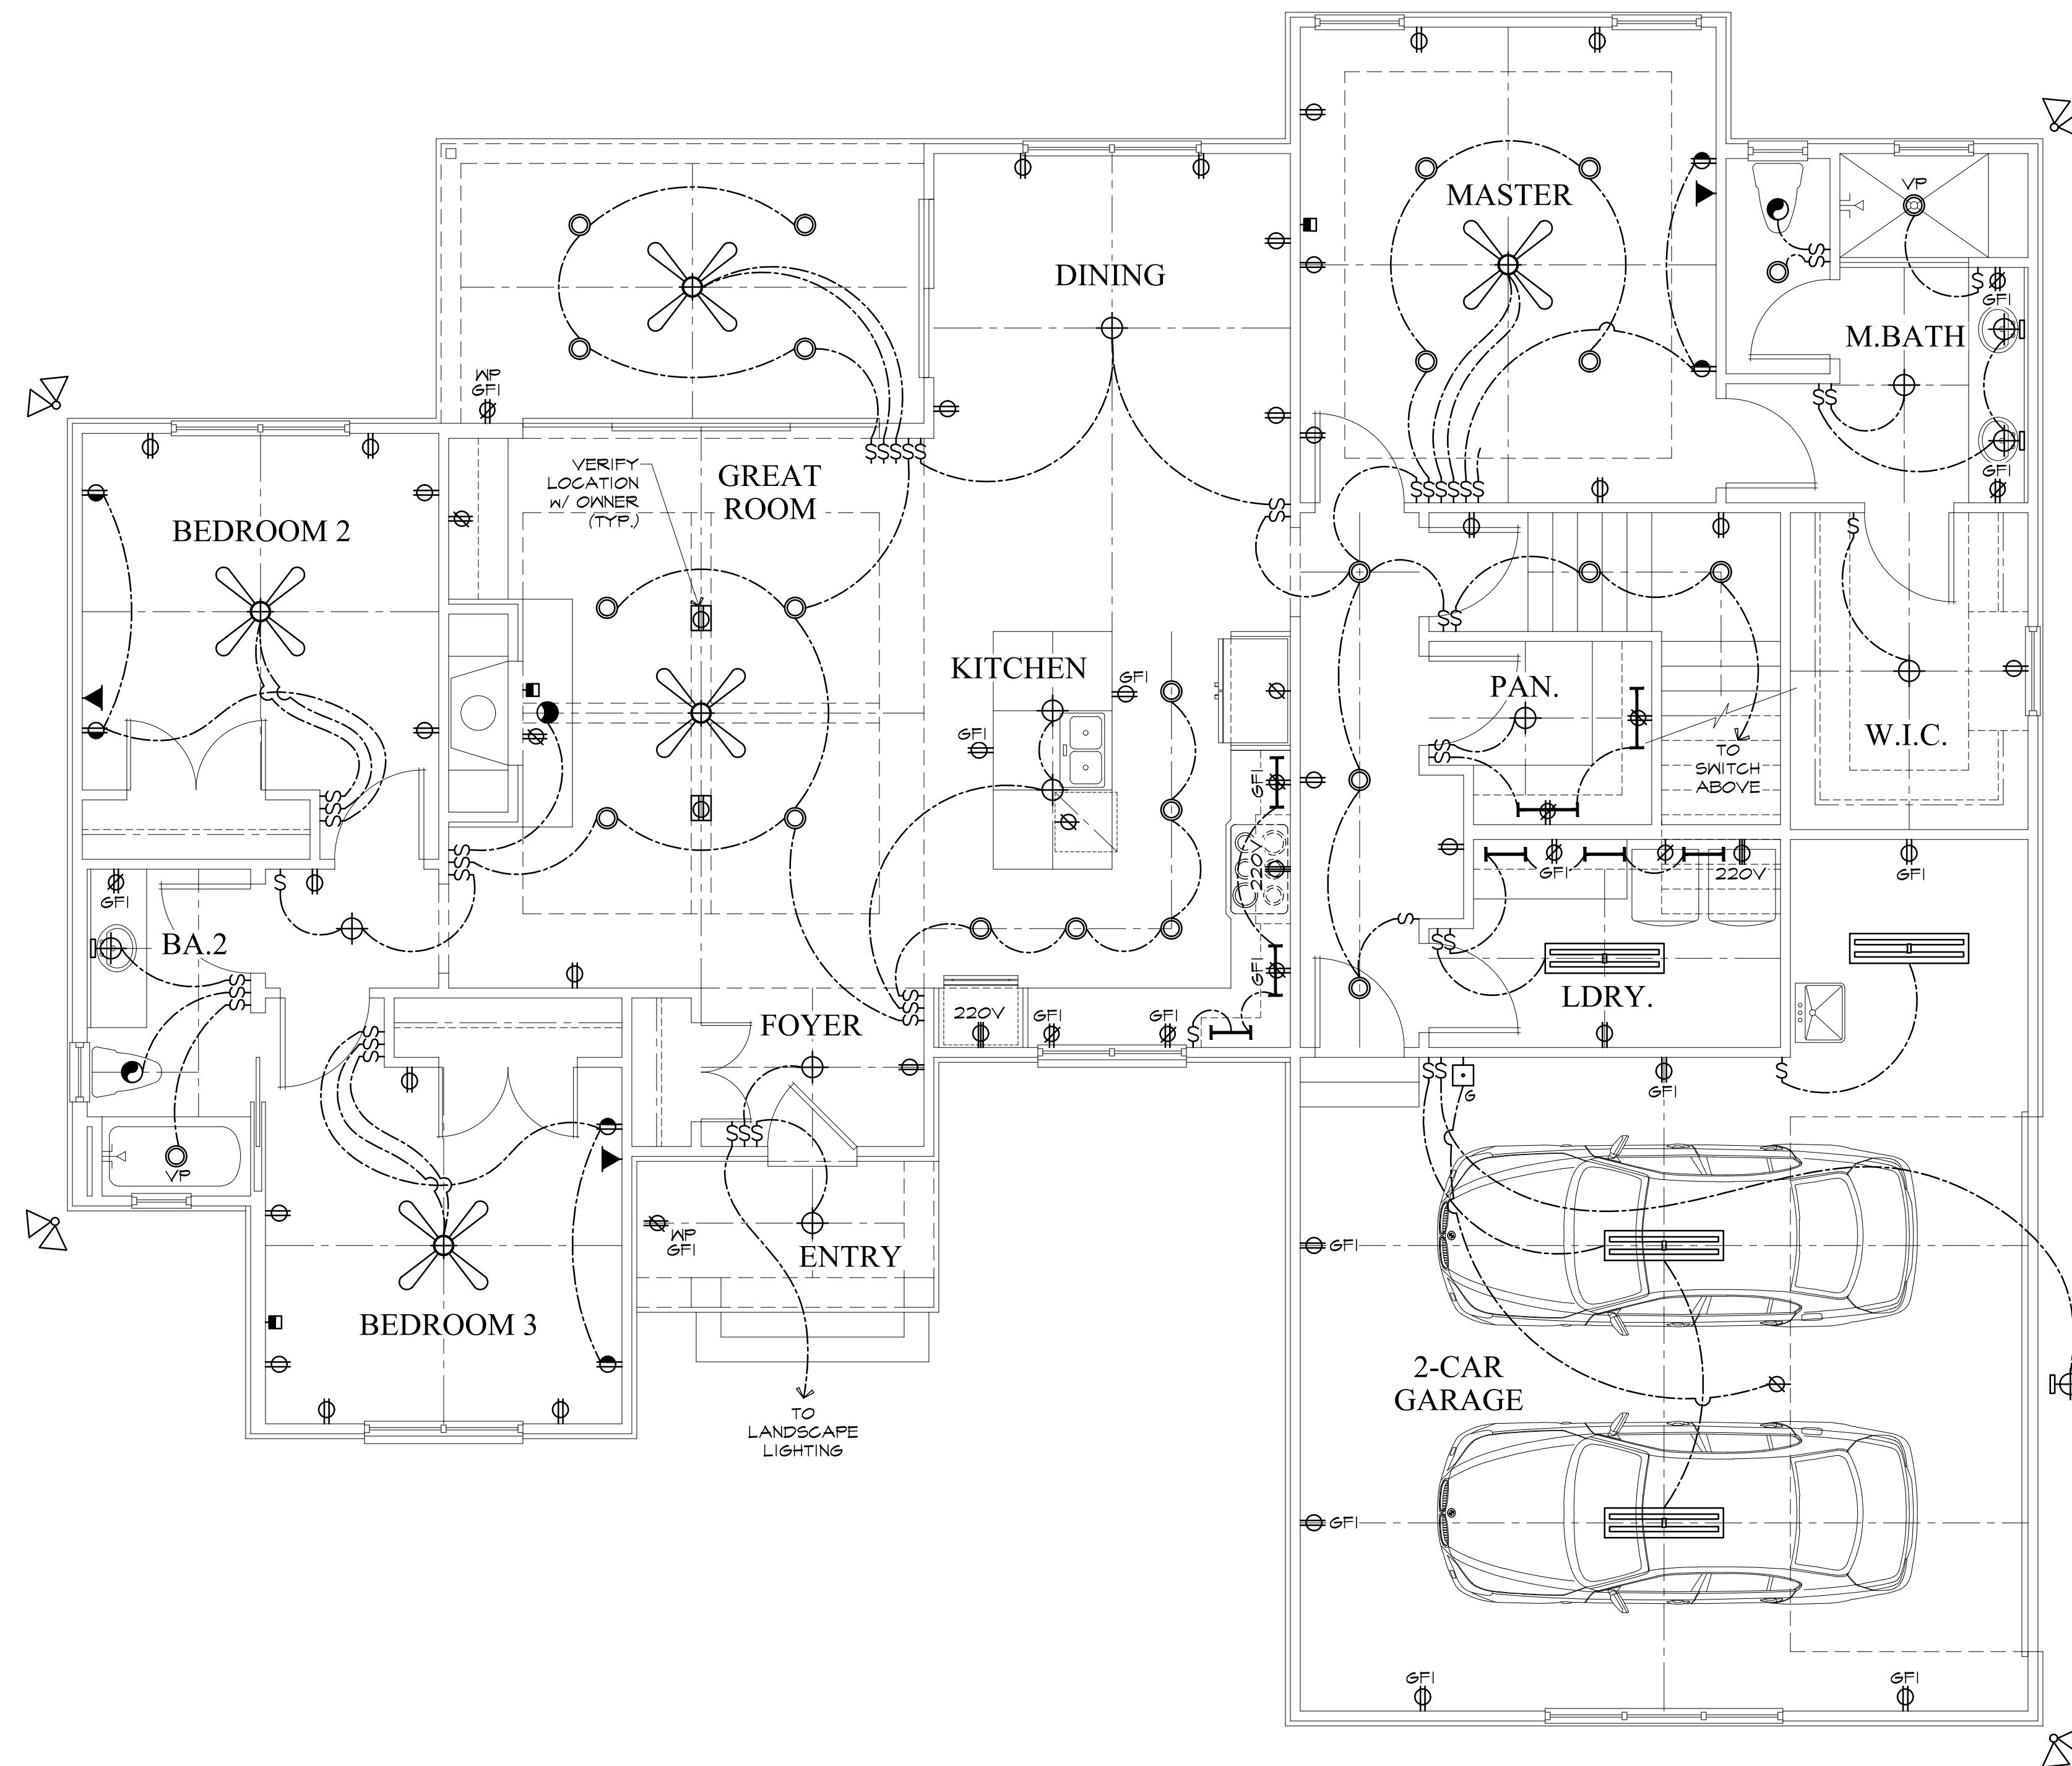


**FIRST FLOOR ELECTRICAL**

Scale: 1/4" = 1'-0"

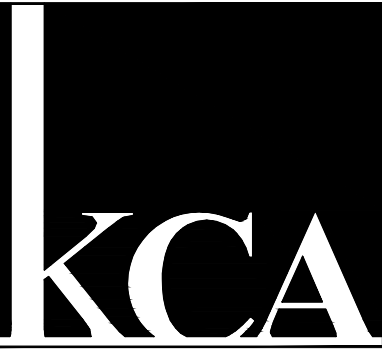

KEVIN  
CULHAN  
*architect, llc*

P O Box 25021  
Greenville, SC 29616  
864-655-7070

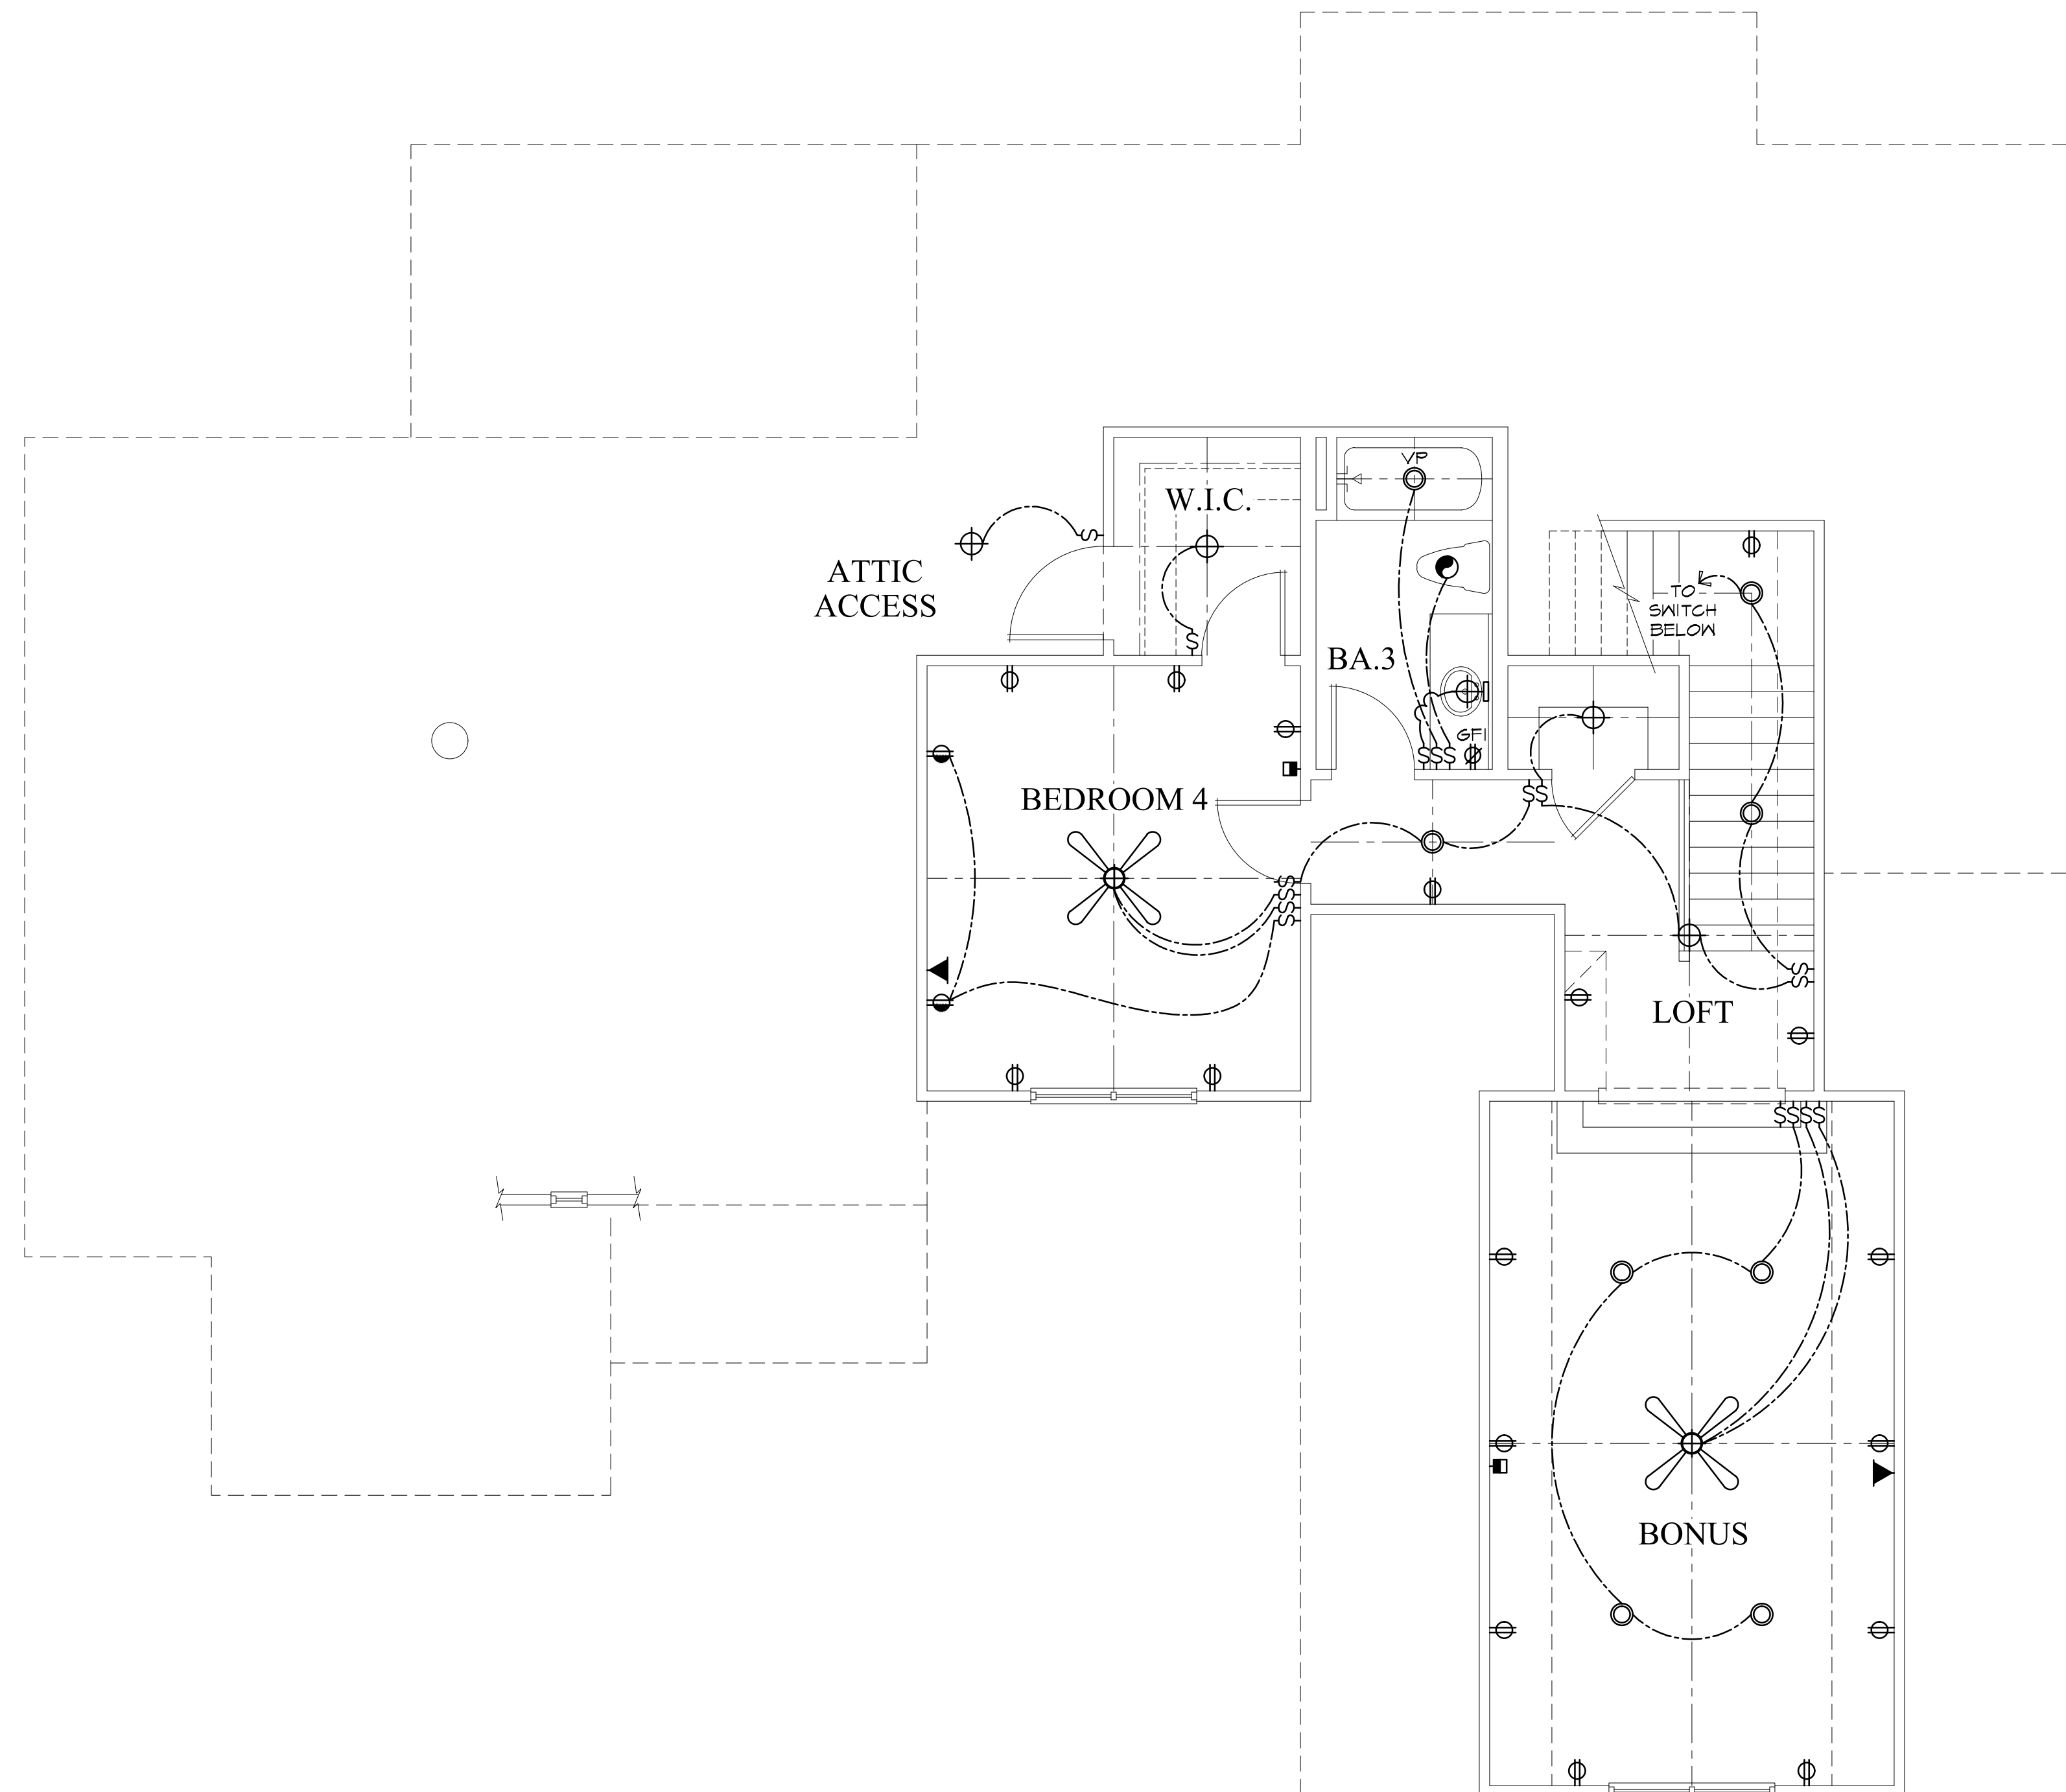

2001 © 1-20-2020 ALL RIGHTS RESERVED BY KEVIN CULHAN ARCHITECT, LLC DO NOT SCALE DRAWINGS

**LOT 85 BRAXTON RIDGE**  
GALLOWAY CUSTOM HOMES

DATE	DESCRIPTION
1-17-20	PRELIM
1-24-20	PRELIM
1-29-20	UPDATE
1-30-20	UPDATE

PROJ. NO: 2001

DRAWN BY: TS

SECOND FLOOR  
ELECTRICAL

SHEET  
10 OF 10

**SECOND FLOOR ELECTRICAL**

Scale: 1/4" = 1'-0"